


1 FLOOR PLAN  
A2 SCALE: 1/4" = 1'

NOTE:  
ELECTRICAL ARRANGEMENT SHOWN ON THIS DRAWING IS DIAGRAMMATIC AND SHOWS ONLY GENERAL LOCATIONS FOR ELECTRICAL COMPONENTS. IT IS THE RESPONSIBILITY OF THE ELECTRICAL SUBCONTRACTOR TO DESIGN AND SIZE ALL COMPONENTS TO COMPLY WITH CURRENT CODE REQUIREMENTS FOR A PRACTICAL, EFFICIENT, & COMPLETE ELECTRICAL SYSTEM.

ELECTRICAL LEGEND	
SYMBOL	DESCRIPTION
	RECESSED LIGHT FIXTURE
	CEILING MOUNTED LIGHT FIXTURE
	WALL MOUNT LIGHT FIXTURE
	VENT
	SMOKE DETECTOR
	220 V. DUPLEX RECEPTACLE OUTLET
	110 V. DUPLEX RECEPTACLE OUTLET
	110 V. FLOOR OUTLET
	GROUND FAULT INTERRUPTER DUPLEX RECEPTACLE OUTLET
	WATER PROOF OUTLET
	SINGLE POLE SWITCH
	2 WAY SWITCH
	DIMMER SWITCH
	2 WAY SWITCH WITH DIMMER
	PUSH BUTTON FOR GARAGE DOOR
	DOOR BELL
	CHIME
	TELEVISION JACK
	PHONE JACK
	GAS LINE CONNECTION
	GARAGE DOOR OPENER
	JUNCTION BOX

ABBREVIATIONS			
SH	SINGLE HUNG	EB	EYE BROW
DL	DIVIDED LIGHTS	PKT	POCKET
HD	HEADER	DR	DOOR
HT	HEIGHT	FG	FIXED GLASS
OH	OVERHEAD	OSBG	OBSCURED GLASS
SECT	SECTIONAL	/ BTH	HALF BATH
CLG	CEILING	MSTR	MASTER
PAN	PANTRY	W.I.C.	WALK-IN CLOSET
RM	ROOM	DBL	DOUBLE
CLST	CLOSET	SNK	SINK
SHLVS	SHELVES	DW	DISH WASHER
CW	COLD WATER TAP		

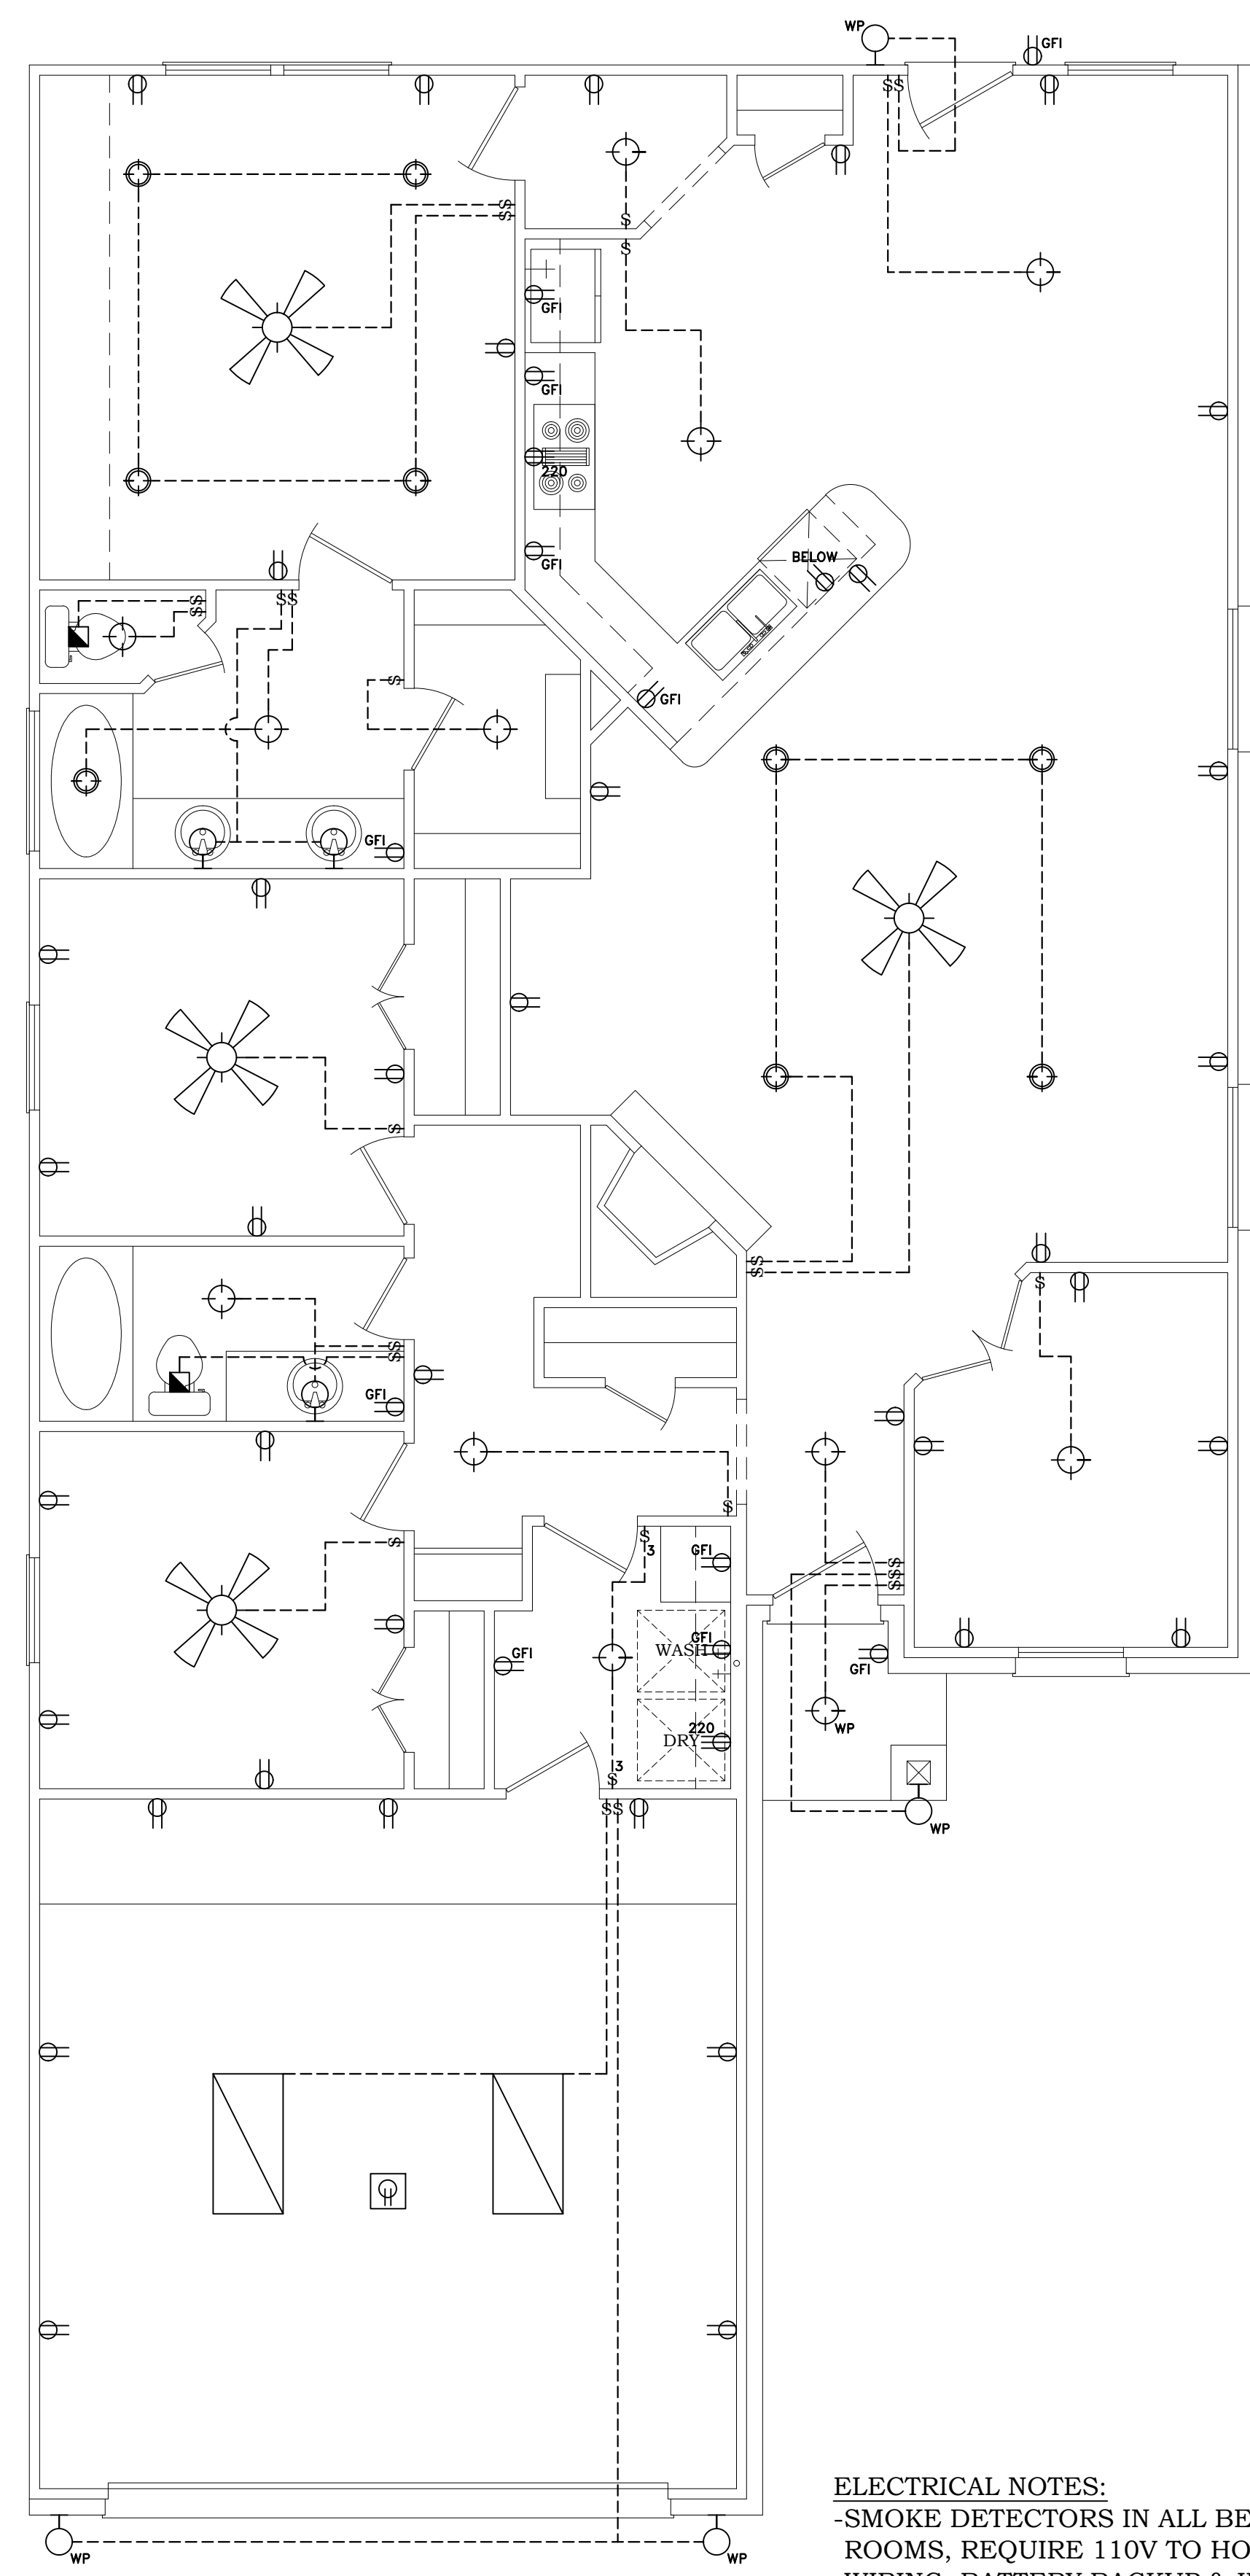

2 ELECTRICAL  
A2 SCALE: 1/4" = 1'

ELECTRICAL NOTES:  
-SMOKE DETECTORS IN ALL BED ROOMS, REQUIRE 110V TO HOUSE WIRING, BATTERY BACKUP & INTERCONNECT  
-VENT ALL EXHAUST FANS TO OUTSIDE  
-PROVIDE G.F.I. PROTECTION ON BATH PLUGS  
-PROVIDE LIGHT FIXTURE & SMOKE DETECTORS AT WATER HEATER & A/C UNIT  
-PROVIDE ELECTRIC DISCONNECT AT A/C UNIT

MOONLIGHT HOUSE PLANS IS A DRAFTING FIRM, NOT AN ENGINEERING OR ARCHITECTURAL FIRM. THESE PRINTS ARE NOT TO BE USED FOR CONSTRUCTION. MOONLIGHT HOUSE PLANS IS NOT RESPONSIBLE FOR ANY STRUCTURAL OR DESIGN MISTAKES. DIMENSIONS, DETAILS & SPECIFICATIONS. THESE DRAWINGS SPECIFICALLY AND READ ARE THE PROPERTY OF MOONLIGHT HOUSE PLANS, AND SHALL NOT BE REPRODUCED, OR ALTERED IN ANY WAY.

Moonlight House Plans  
979-482-1967

REVISION HISTORY	DATE
NUMBER	

DWG. SCALE: 1/4" = 1'-0"

FLOOR PLAN  
GEMSTONE GROUP LLC  
SPEC HOME  
JOB #: 20101051

08-18-10

A2